





 






Legend

-  Zno. Reggiani Kaze LED fittings
-  Reggiani Sunios
-  Reggiani Lorosae pendant
-  GE Lighting Brio
-  Erco Trion
-  ASD Horizon
-  Emergency light
-  Existing extract
-  TSSO
-  Switched spur
-  Data input/outlet

Switching to Kaze and Sunios fittings to be multigang in pairs across church & up and down lights switched separately - main panel by porch

The title, copyright and confidential information in this document belongs to Mark Goodwill-Hodgson Ltd. © 2012. All rights reserved.

No dimensions to be scaled off this drawing.

All dimensions to be checked on site before work commences and any discrepancies reported to the architect.

This drawing to be read in conjunction with other drawings issued by the architect.

Notes

New glazed external door

Lower floor to chancel to match nave with single step to altar platform and re-used timber paneling to line walls

New raised floor finish to nave, tower, aisles & into chancel in engineered oak boarding with stone altar platform

Relocate reredos to east wall and lower in height. Infill panels in matching timber

Remove rood screen but keep beam and cross and suspend higher in chancel arch

Remove pews & provide pew chairs for adaptable layout and forward altar, reader's desks and new lectern


New twin gas boilers and panel radiators to heat church - design by specialist
Add heating to porch

New up and downlights to nave, aisles and chancel with additional spots - All LED

New sound and projection systems with motorised screen to rear rood beam

New clear glazing to leaded lights to tower screen.
New storage cupboards and desk improve access to tower & organ

Redecorate throughout

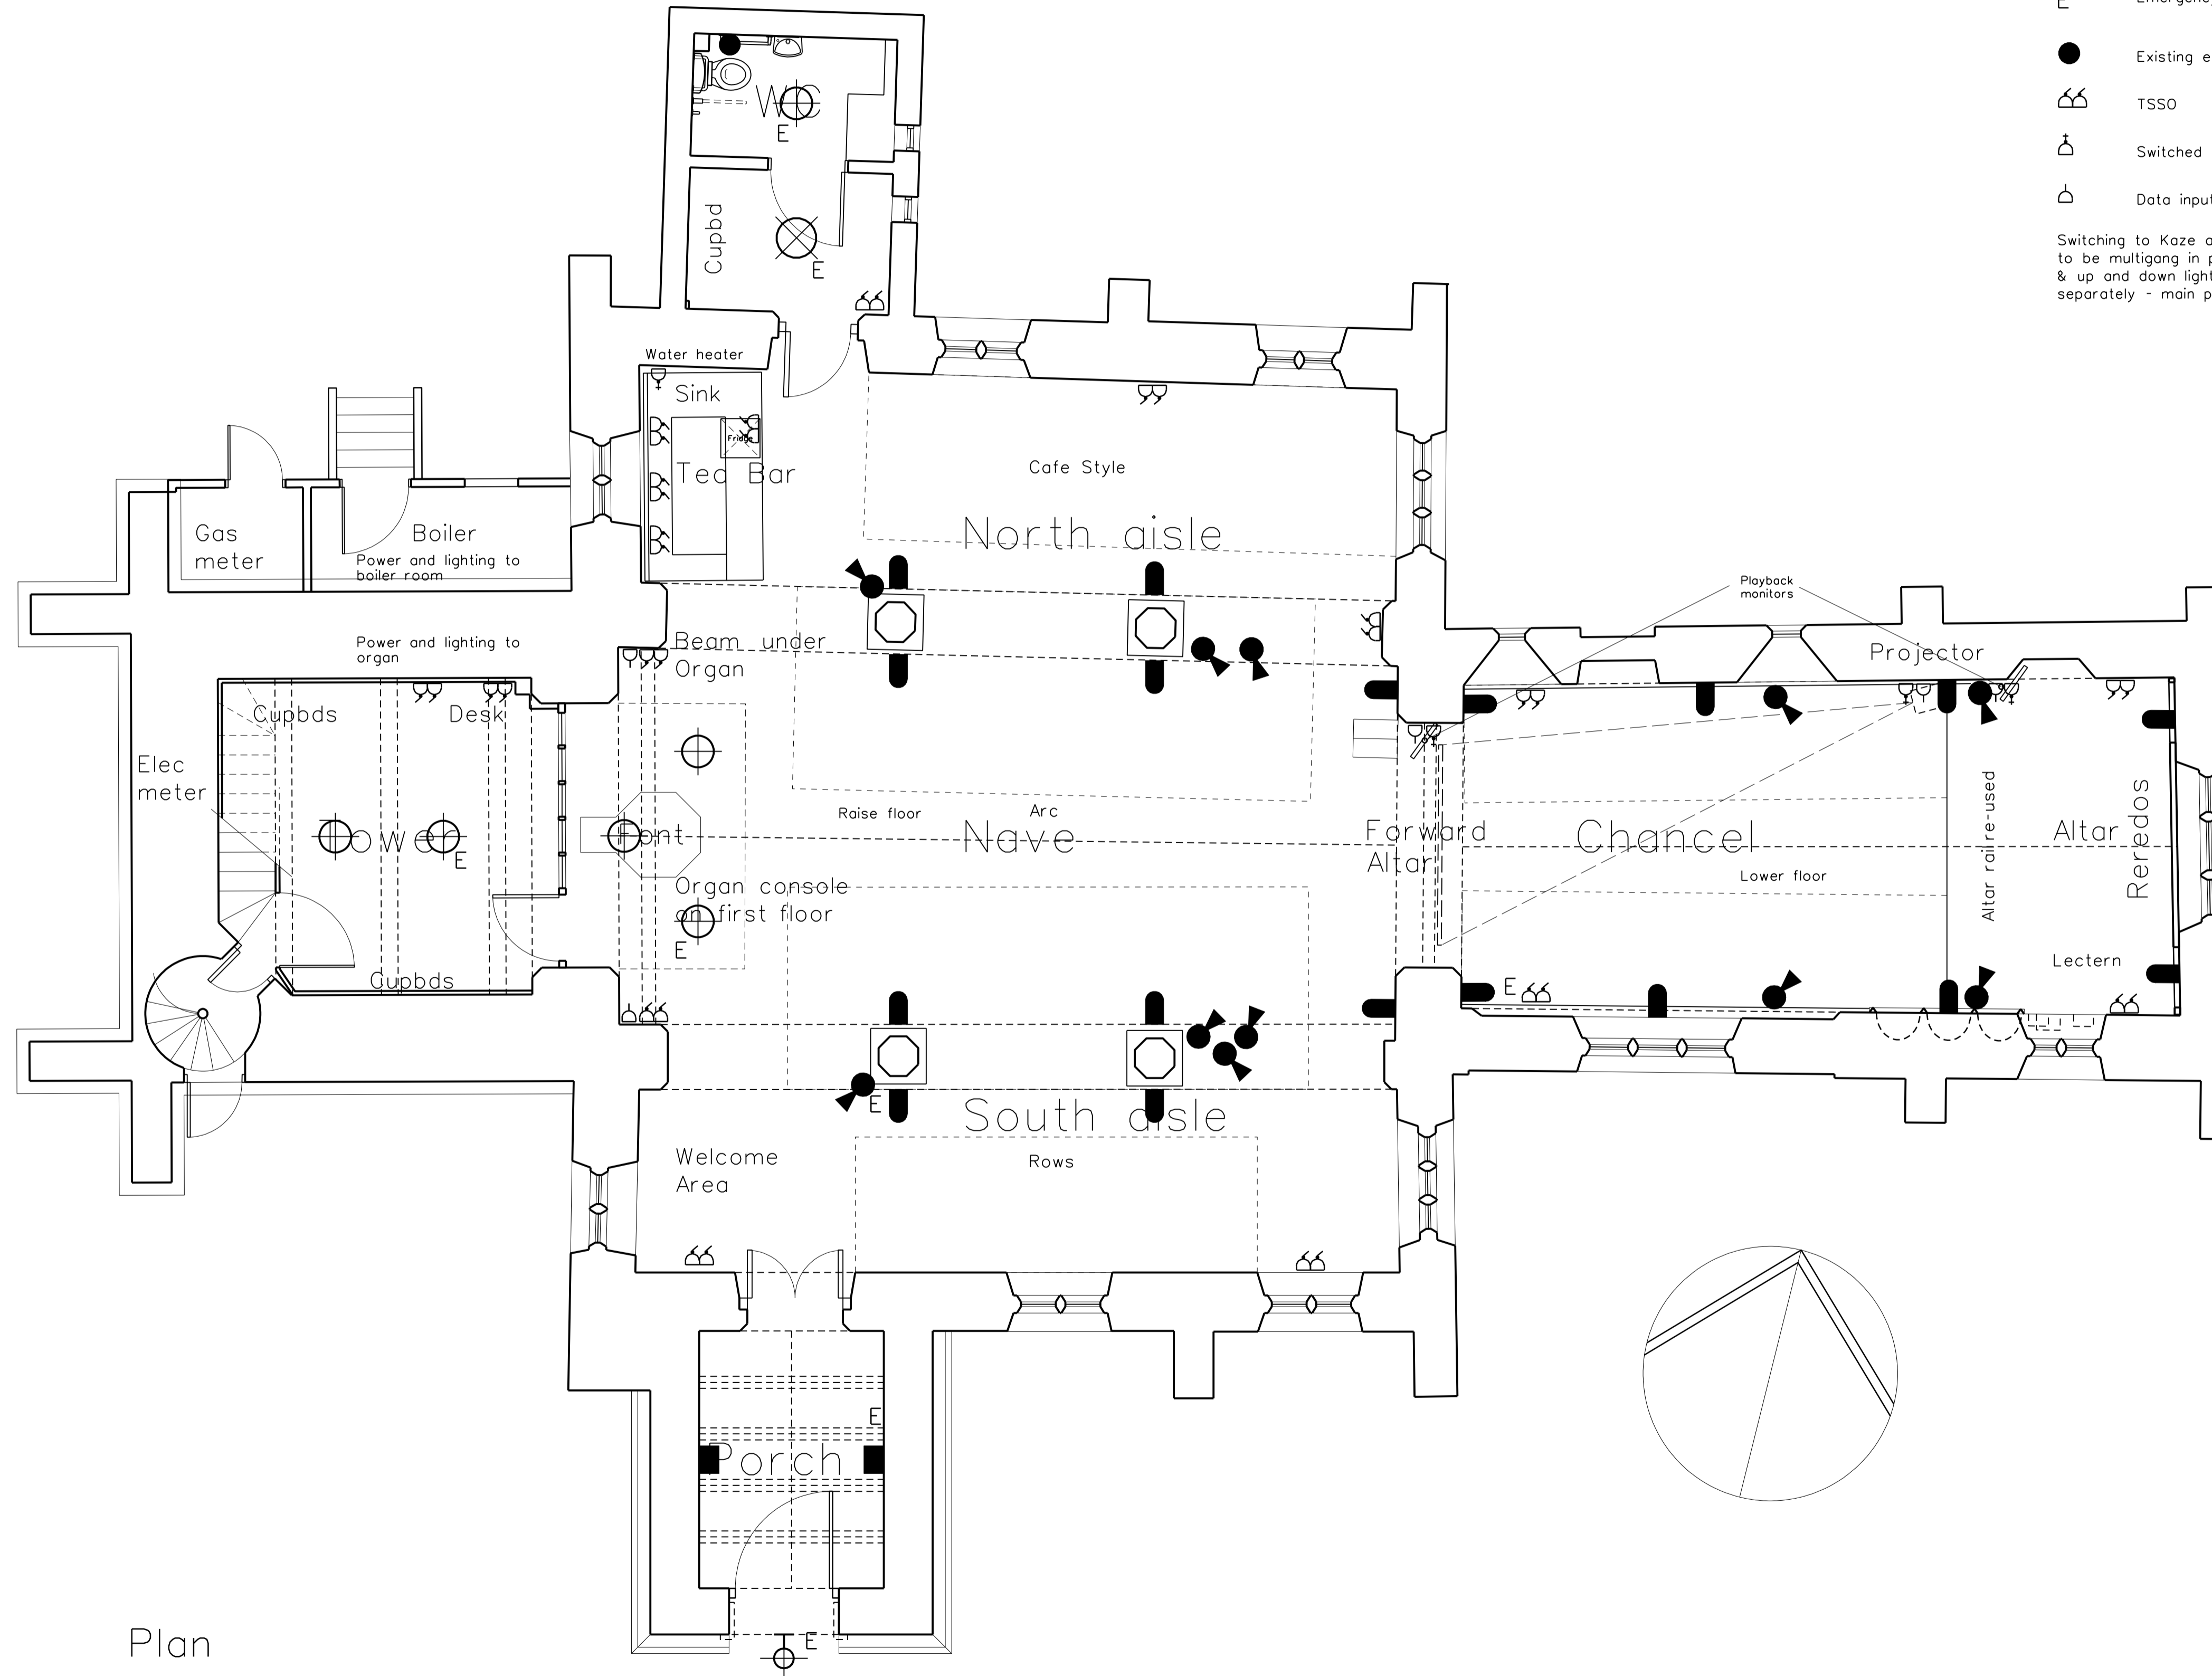

Plan

Rev.	Date	Initials

Notes

MARK GOODWILL-HODGSON LTD
Specialist Conservation Architect
1 Highfield Road West Bridgford
Nottingham NG2 6DR 07970 692 887
markgoodwillhodgson@gmail.com

Client
St Helens PCC
Trowell

Job
Re-ordering

Drawing
Proposed plan
Electrical layout

Job Number	Drawing Number	Revision
pr1440	L(60)01	
Scale	Status	Date
1:100	faculty	02.02.15

Original Sheet Size A1